



**Brentwood Clinic
Sandcreek Building #4**
171 Sand Creek Road
Martinez, CA 94513

approved for the owner by:

approved for the architect by:



Lic# 754354
2420 Sand Creek Rd., C1-341
Brentwood, CA. 94513
(925) 240-6024

THE WITHIN DESIGN IS THE SOLE AND EXCLUSIVE PROPERTY OF RODDA ELECTRIC AND IS NOT TO BE REPRODUCED OR TRANSMITTED IN ANY FORM OR BY ANY MEANS, ELECTRONIC OR MECHANICAL, INCLUDING PHOTOCOPYING, RECORDING, OR BY ANY INFORMATION STORAGE AND RETRIEVAL SYSTEM, WITHOUT THE WRITTEN PERMISSION OF RODDA ELECTRIC. THIS DESIGN IS SOLELY FOR THE PURPOSE OF EFFECTING A SALE OF THE DELINEATED ELECTRICAL DESIGN OR INSTALLATION TO CUSTOMERS OR PROSPECTIVE CUSTOMERS OF RODDA ELECTRIC.

drawn by: BCE plot date: 10/18/04


checked by: RE

stamp

scale: 1/4" = 1'-0"

project number: 04-111

**LIGHTING
PLAN**

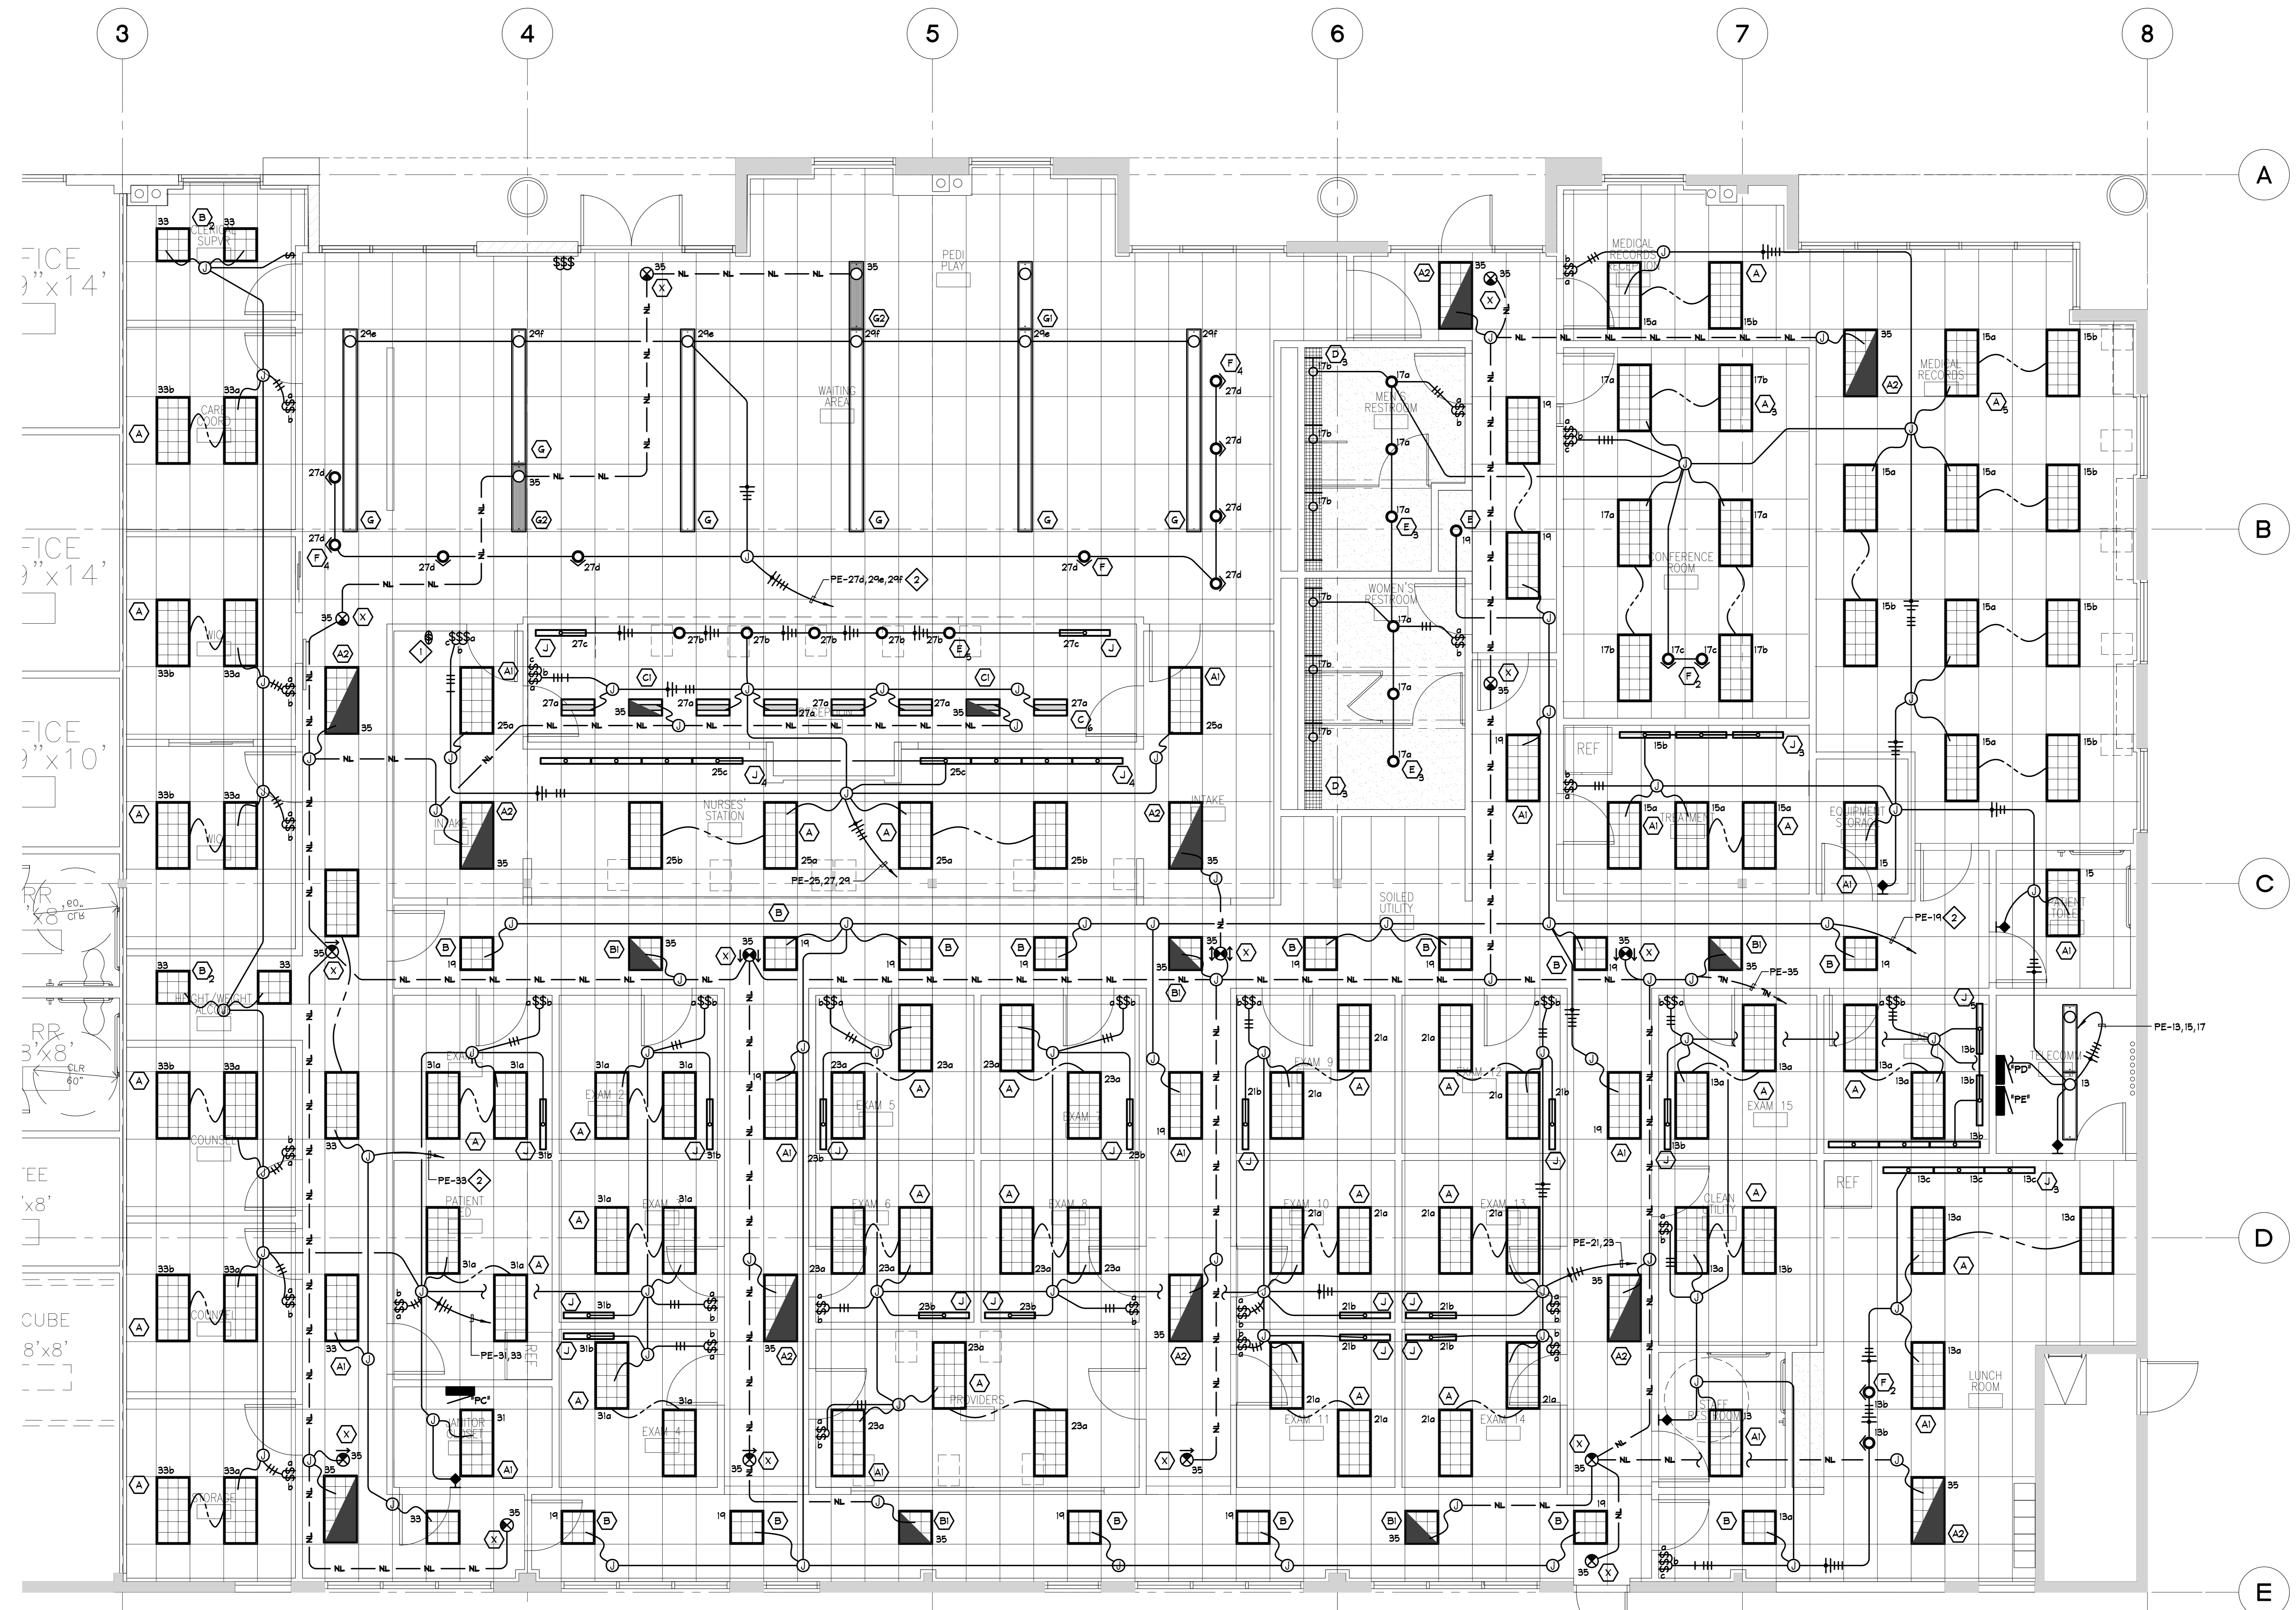

- SHEET NOTES:**
- 1. INSTALL (S) LOW VOLTAGE MOMENTARY CONTACT SWITCHES TO CONTROL THE FOLLOWING CIRCUITS:
 - 19 CORRIDOR LIGHTING
 - 23 CORRIDOR LIGHTING
 - 27d WAITING AREA WALL WASHERS
 - 29a WAITING AREA INDIRECTS
 - 29f WAITING AREA INDIRECTS
 - RUN (6) #18 AWG LOW VOLTAGE WIRES TO LIGHTING CONTROL PANEL "LCP"
 - 2. RUN CIRCUITS HOME TO PANEL "PE" VIA RELAYS IN LIGHTING CONTROL PANEL "LCP" SEE DETAIL 2/E01.

1 LIGHTING PLAN
1/4"=1'-0"