



**Brentwood Clinic
Sandcreek Building #4**
171 Sand Creek Road
Martinez, CA 94513

approved for the owner by :

approved for the architect by :



Lic# 754354
2420 Sand Creek Rd., C1-341
Brentwood, CA. 94513
(925) 240-6024

THIS DESIGN IS THE SOLE AND EXCLUSIVE PROPERTY OF RODDA ELECTRIC, AND IS NOT TO BE COPIED OR REPRODUCED IN WHOLE OR IN PART BY ANY OTHER PERSON. EXHIBITION HEREOF IS SOLELY FOR THE PURPOSE OF EFFECTING A SALE OF THE DELINEATED ELECTRICAL DESIGN OR INSTALLATION TO CUSTOMERS OR PROSPECTIVE CUSTOMERS OF RODDA ELECTRIC.

drawn by : BCE plot date : 10/18/04

checked by : FE


stamp

scale : 1/4" = 1'-0"

project number : 04-111

ROOF POWER PLAN

sheet no. : **E-2.2**

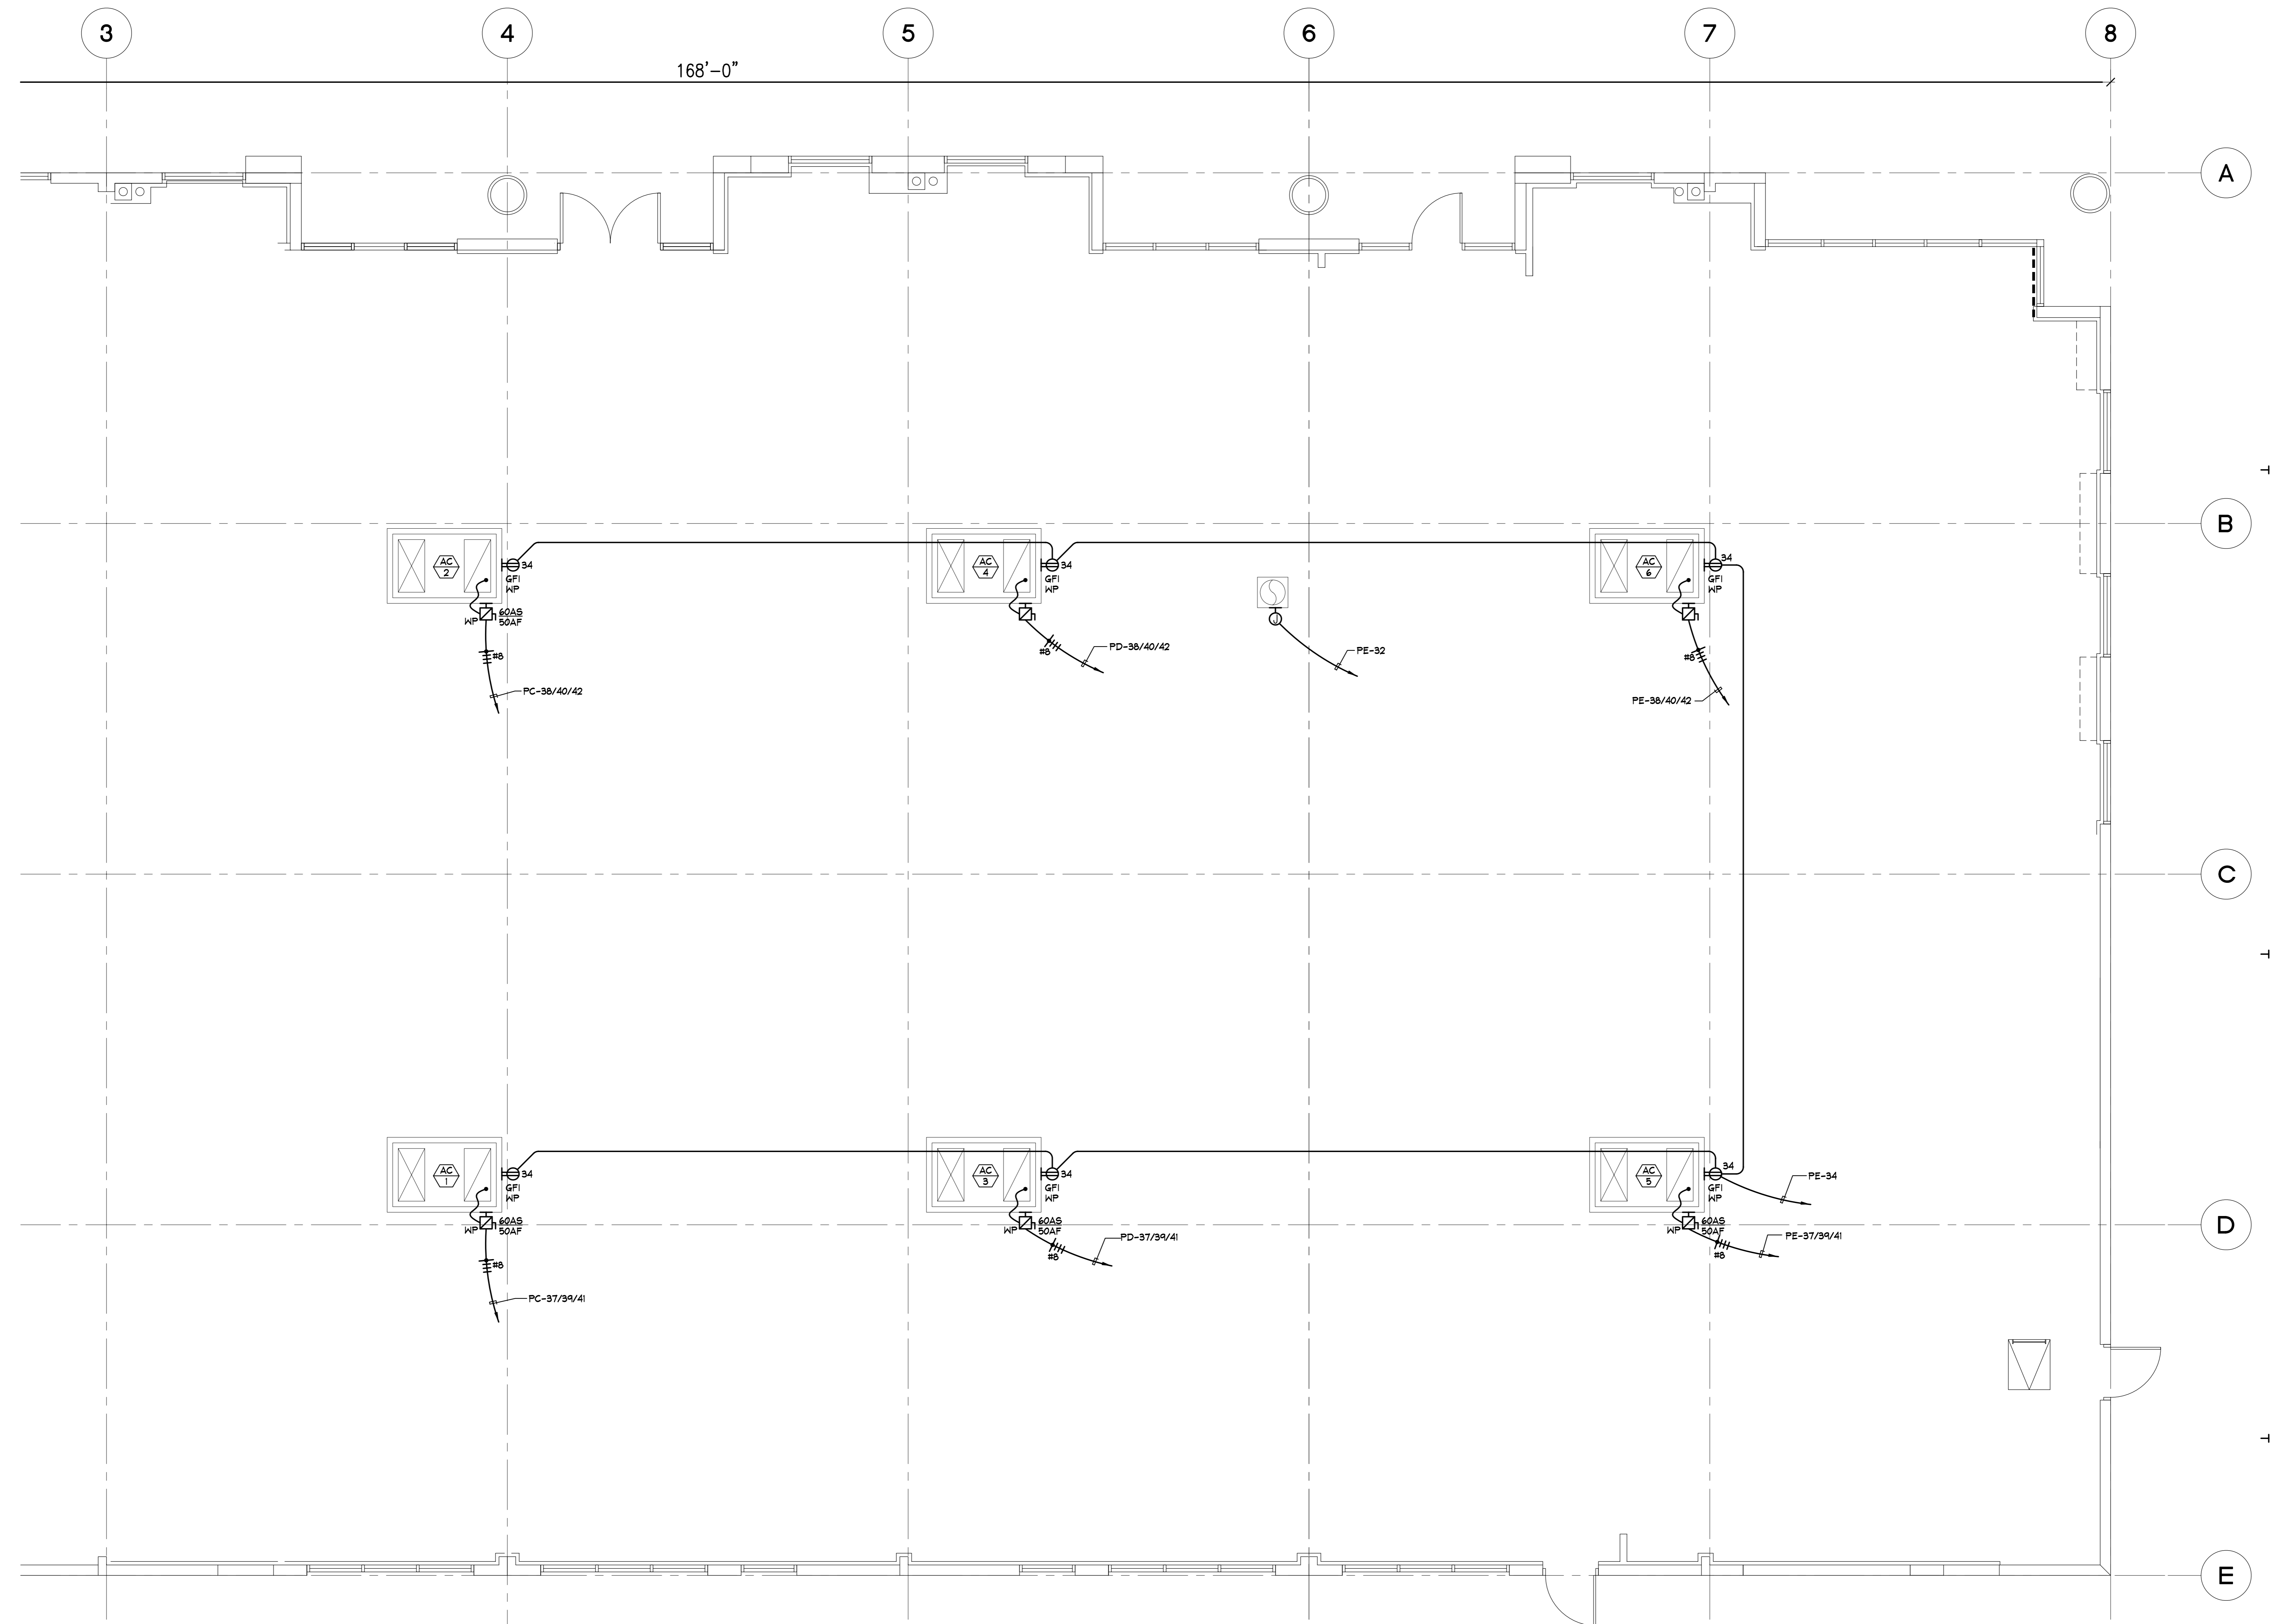

1 ROOF POWER PLAN
1/4"=1'-0"