


SAND CREEK
BUSINESS CENTER
PHASE III

Keller-Williams
191 SANDCREEK RD
BRENTWOOD,
CA. 94513

EEl Elson Electric, Inc.
Office: (925) 240-7913 288 Wilbrey Lane Brentwood, Ca. 94513
Fax: (925) 634-2073 C10-783119


REV.	BY	DESCRIPTION	DATE
-	EEL	ISSUED FOR PERMIT	04.19.06

THIS DESIGN IS THE SOLE AND EXCLUSIVE PROPERTY OF ELSON ELECTRIC, INC. AND IS NOT TO BE USED, COPIED, OR REPRODUCED, IN WHOLE OR IN PART BY ANY OTHER PERSON. EXHIBITION HEREOF IS SOLELY FOR THE PURPOSE OF EFFECTING A SALE OF THE DELINEATED ELECTRICAL DESIGN OR INSTALLATION TO CUSTOMERS OR PROSPECTIVE CUSTOMERS OF ELSON ELECTRIC, INC.

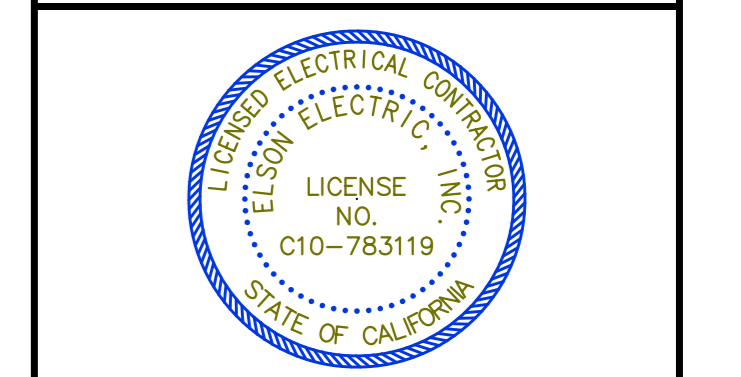

SHEET TITLE
LIGHTING PLAN

DRAWN:	BCE	E-11
CHECKED:	EEL	
DATE:	04.19.06	
SCALE:	1/8" = 1'-0"	
JOB NO.:	06.063	

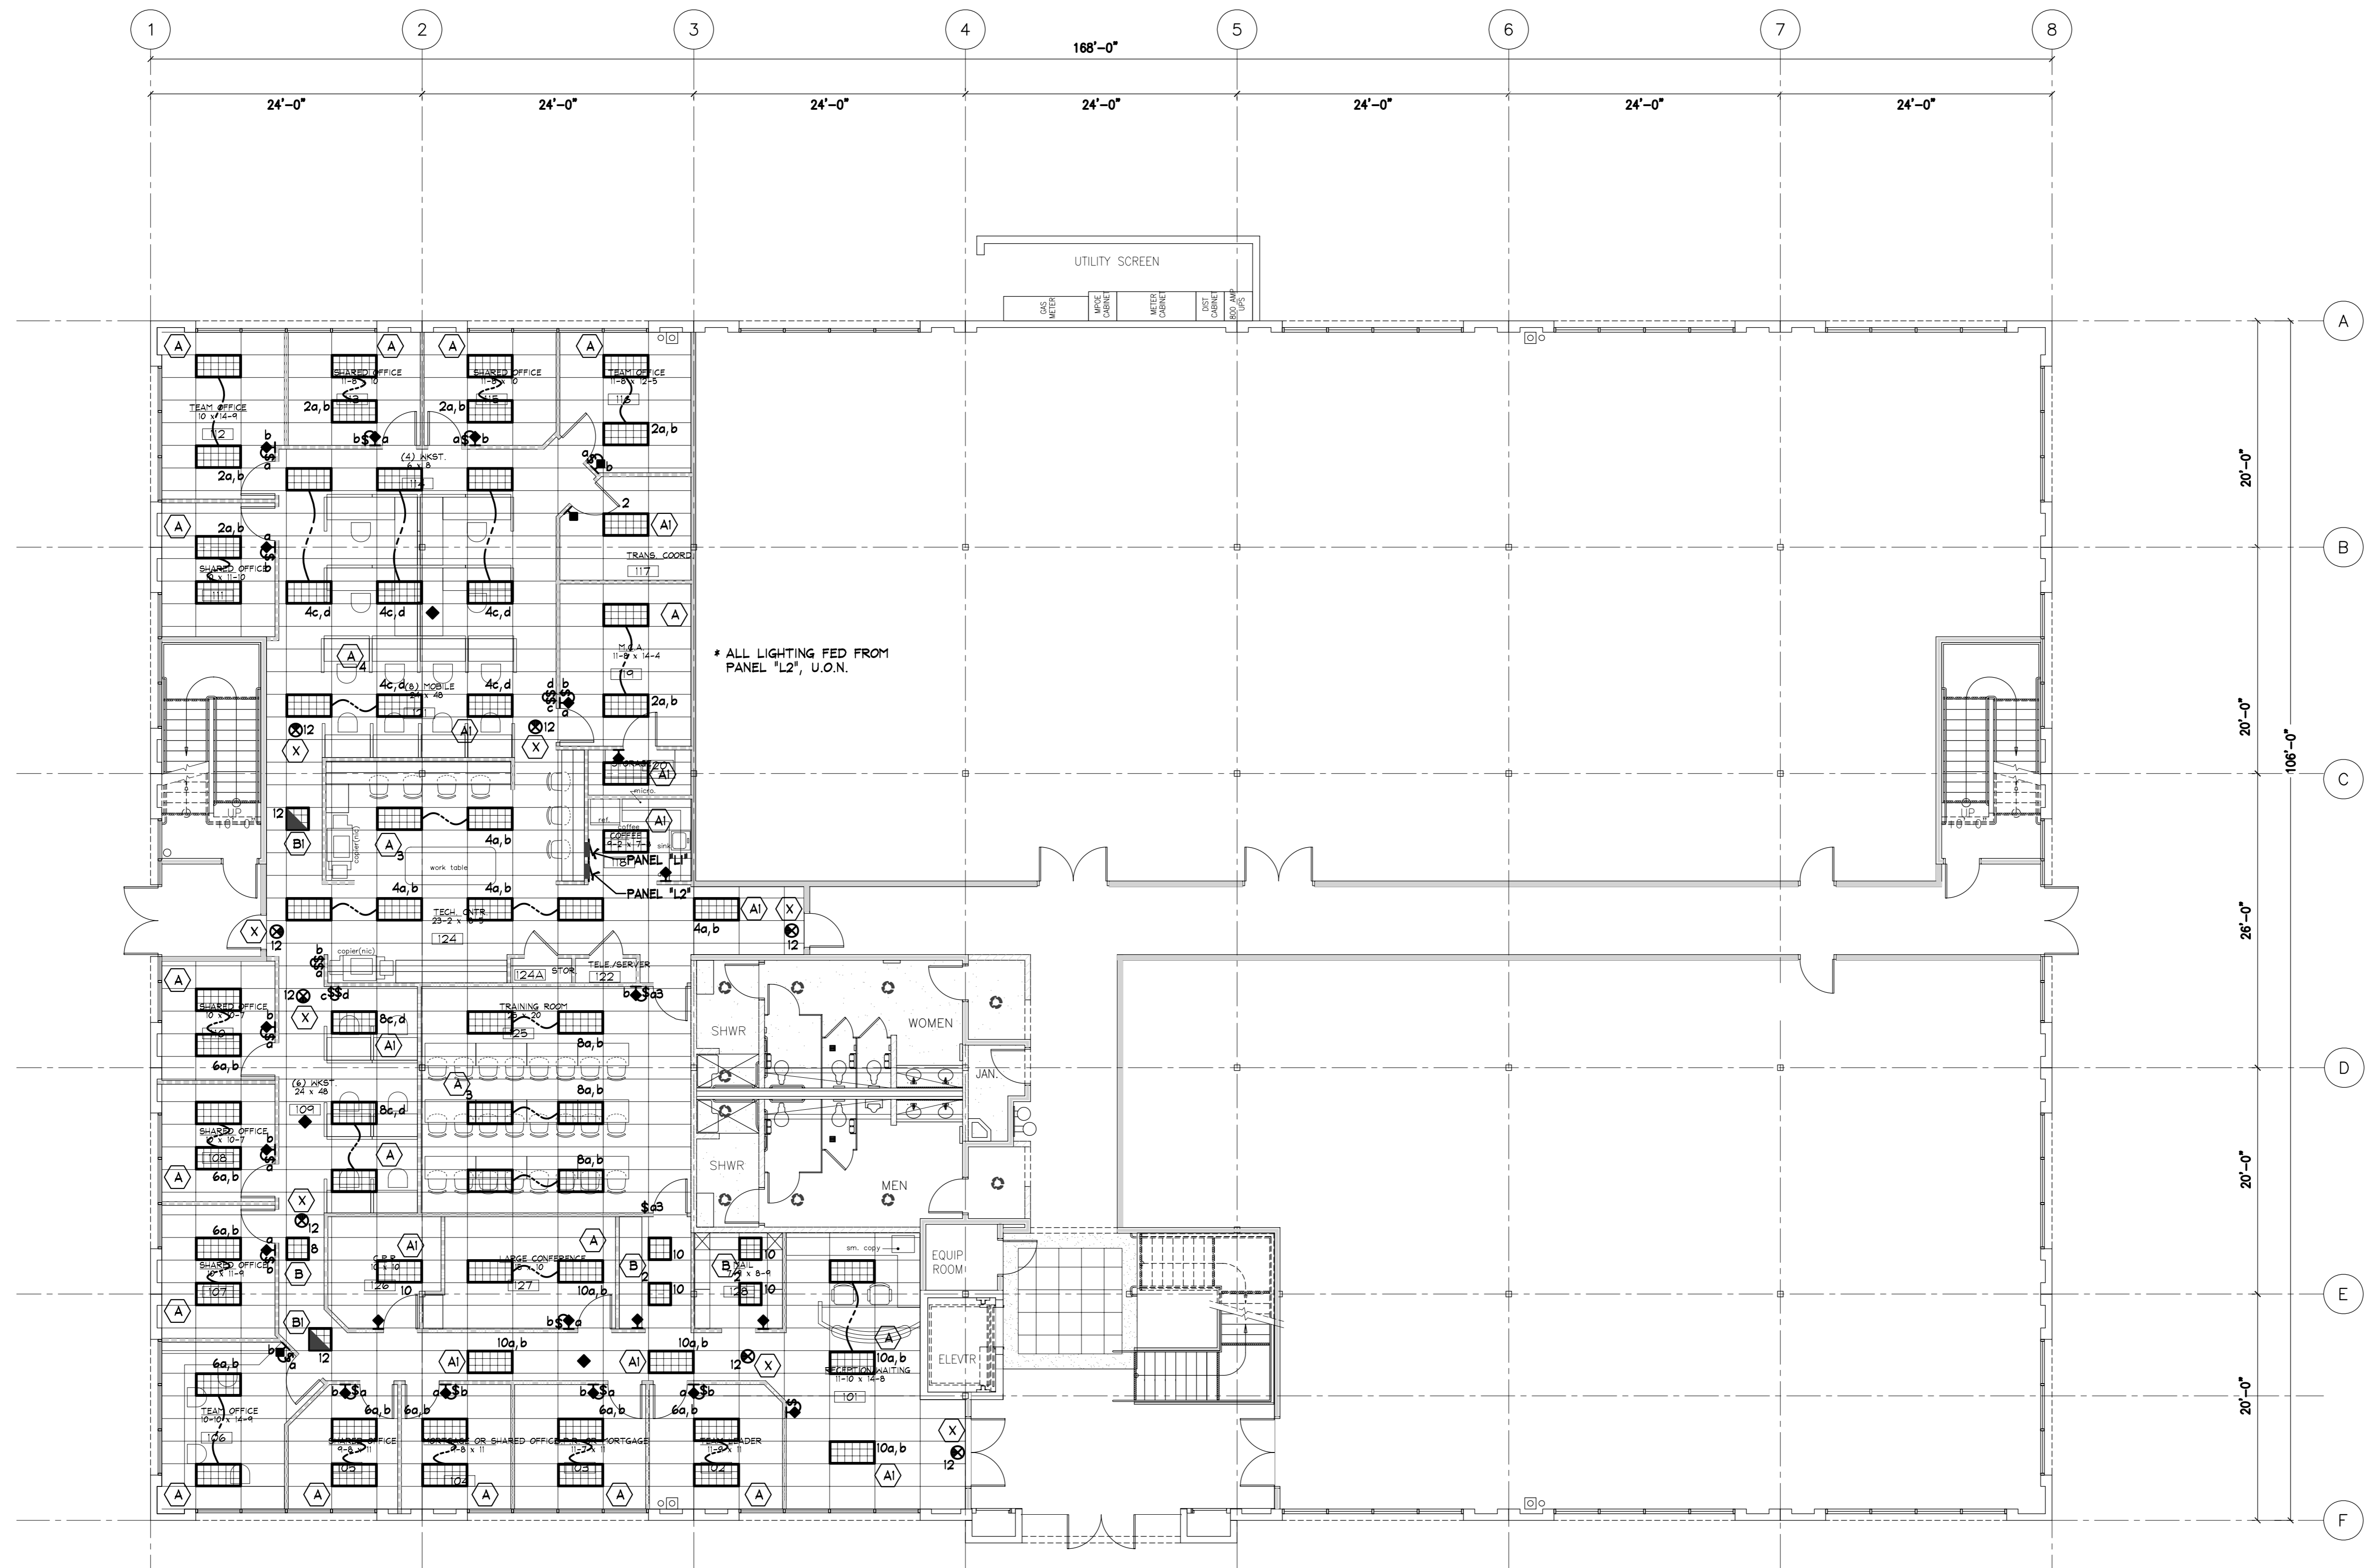

1 1ST FLOOR PLAN (BLDG-2)
1/8" = 1'-0"

1 LIGHTING PLAN
1/8" = 1'-0"