




6210 Stoneridge Mall Road
5th Floor
Pleasanton, CA.



CANSHO ELECTRIC INC. DESIGN / BUILD
16548 SHRYVER TRAIL
PLEASANTON, CA 94566
(925) 485-5999 Fax: (925) 485-5955
LIC. 95700046

THE WHOLE DESIGN IS THE SOLE AND EXCLUSIVE PROPERTY OF CANSHO ELECTRIC INC. AND IS NOT TO BE USED, COPIED OR REPRODUCED IN WHOLE OR IN PART BY ANY OTHER PERSON, COMPANY, FIRM OR INDIVIDUAL WITHOUT THE EXPRESS WRITTEN PERMISSION OF CANSHO ELECTRIC INC. ANY VIOLATION WILL BE PROSECUTED TO THE FULL EXTENT OF THE LAW.

FIXTURE SCHEDULE						
TYPE	MANUFACTURER	DESCRIPTION	LAMPS QTY	DESC.	FIXTURE WATTS	VOLTS
A	LOS ANGELES LIGHTING	2x4 2-LAMP FLUORESCENT LAT-IN FIXTURE W/18 CELL, 3" DEEP PARABOLIC REFLECTOR AND ELECTRONIC BALLAST	2	F032 TB	58	277
A1	LOS ANGELES LIGHTING	SAME AS TYPE "A" EXCEPT WITH EMERGENCY BATTERY PACK	2	F032 TB	58	277
B	LOS ANGELES LIGHTING	2X2 LAY-IN FLUORESCENT FIXTURE WITH 6-CELL PARABOLIC REFLECTOR AND ELECTRONIC BALLAST (2) 1-5/8" U LAMPS	2	F031 TB	27	277
C	CAPRI #PL26 OR APPROVED EQUAL	RECESSED COMPACT FLUORESCENT DOWN LIGHT W/6" DIA. APERTURE CLEAR ALZAK REFLECTOR AND DIMMING BALLAST	2	F13 DTT SP32	27	277
D	CAPRI #PL26 OR APPROVED EQUAL	RECESSED COMPACT FLUORESCENT WALL WASHER W/6" DIA. APERTURE CLEAR ALZAK REFLECTOR AND DIMMING BALLAST	2	F13 DTT SP32	27	277
D1	CAPRI #PL26 OR APPROVED EQUAL	RECESSED COMPACT FLUORESCENT WALL WASHER W/6" DIA. APERTURE AND CLEAR ALZAK REFLECTOR	2	F13 DTT SP32	27	277
E	T.B.D.	LOW VOLTAGE PENDANT LIGHT DIMMABLE	1	35W MR16	35	120/12V
X	PRESTIGE SERIES OR APPROVED EQUAL	LED EDGE LIT EXIT SIGN TO MATCH BUILDING STANDARD; CLEAR PANEL, GREEN LETTERING ARROWS INDICATE DIRECTION	-	-	12	277

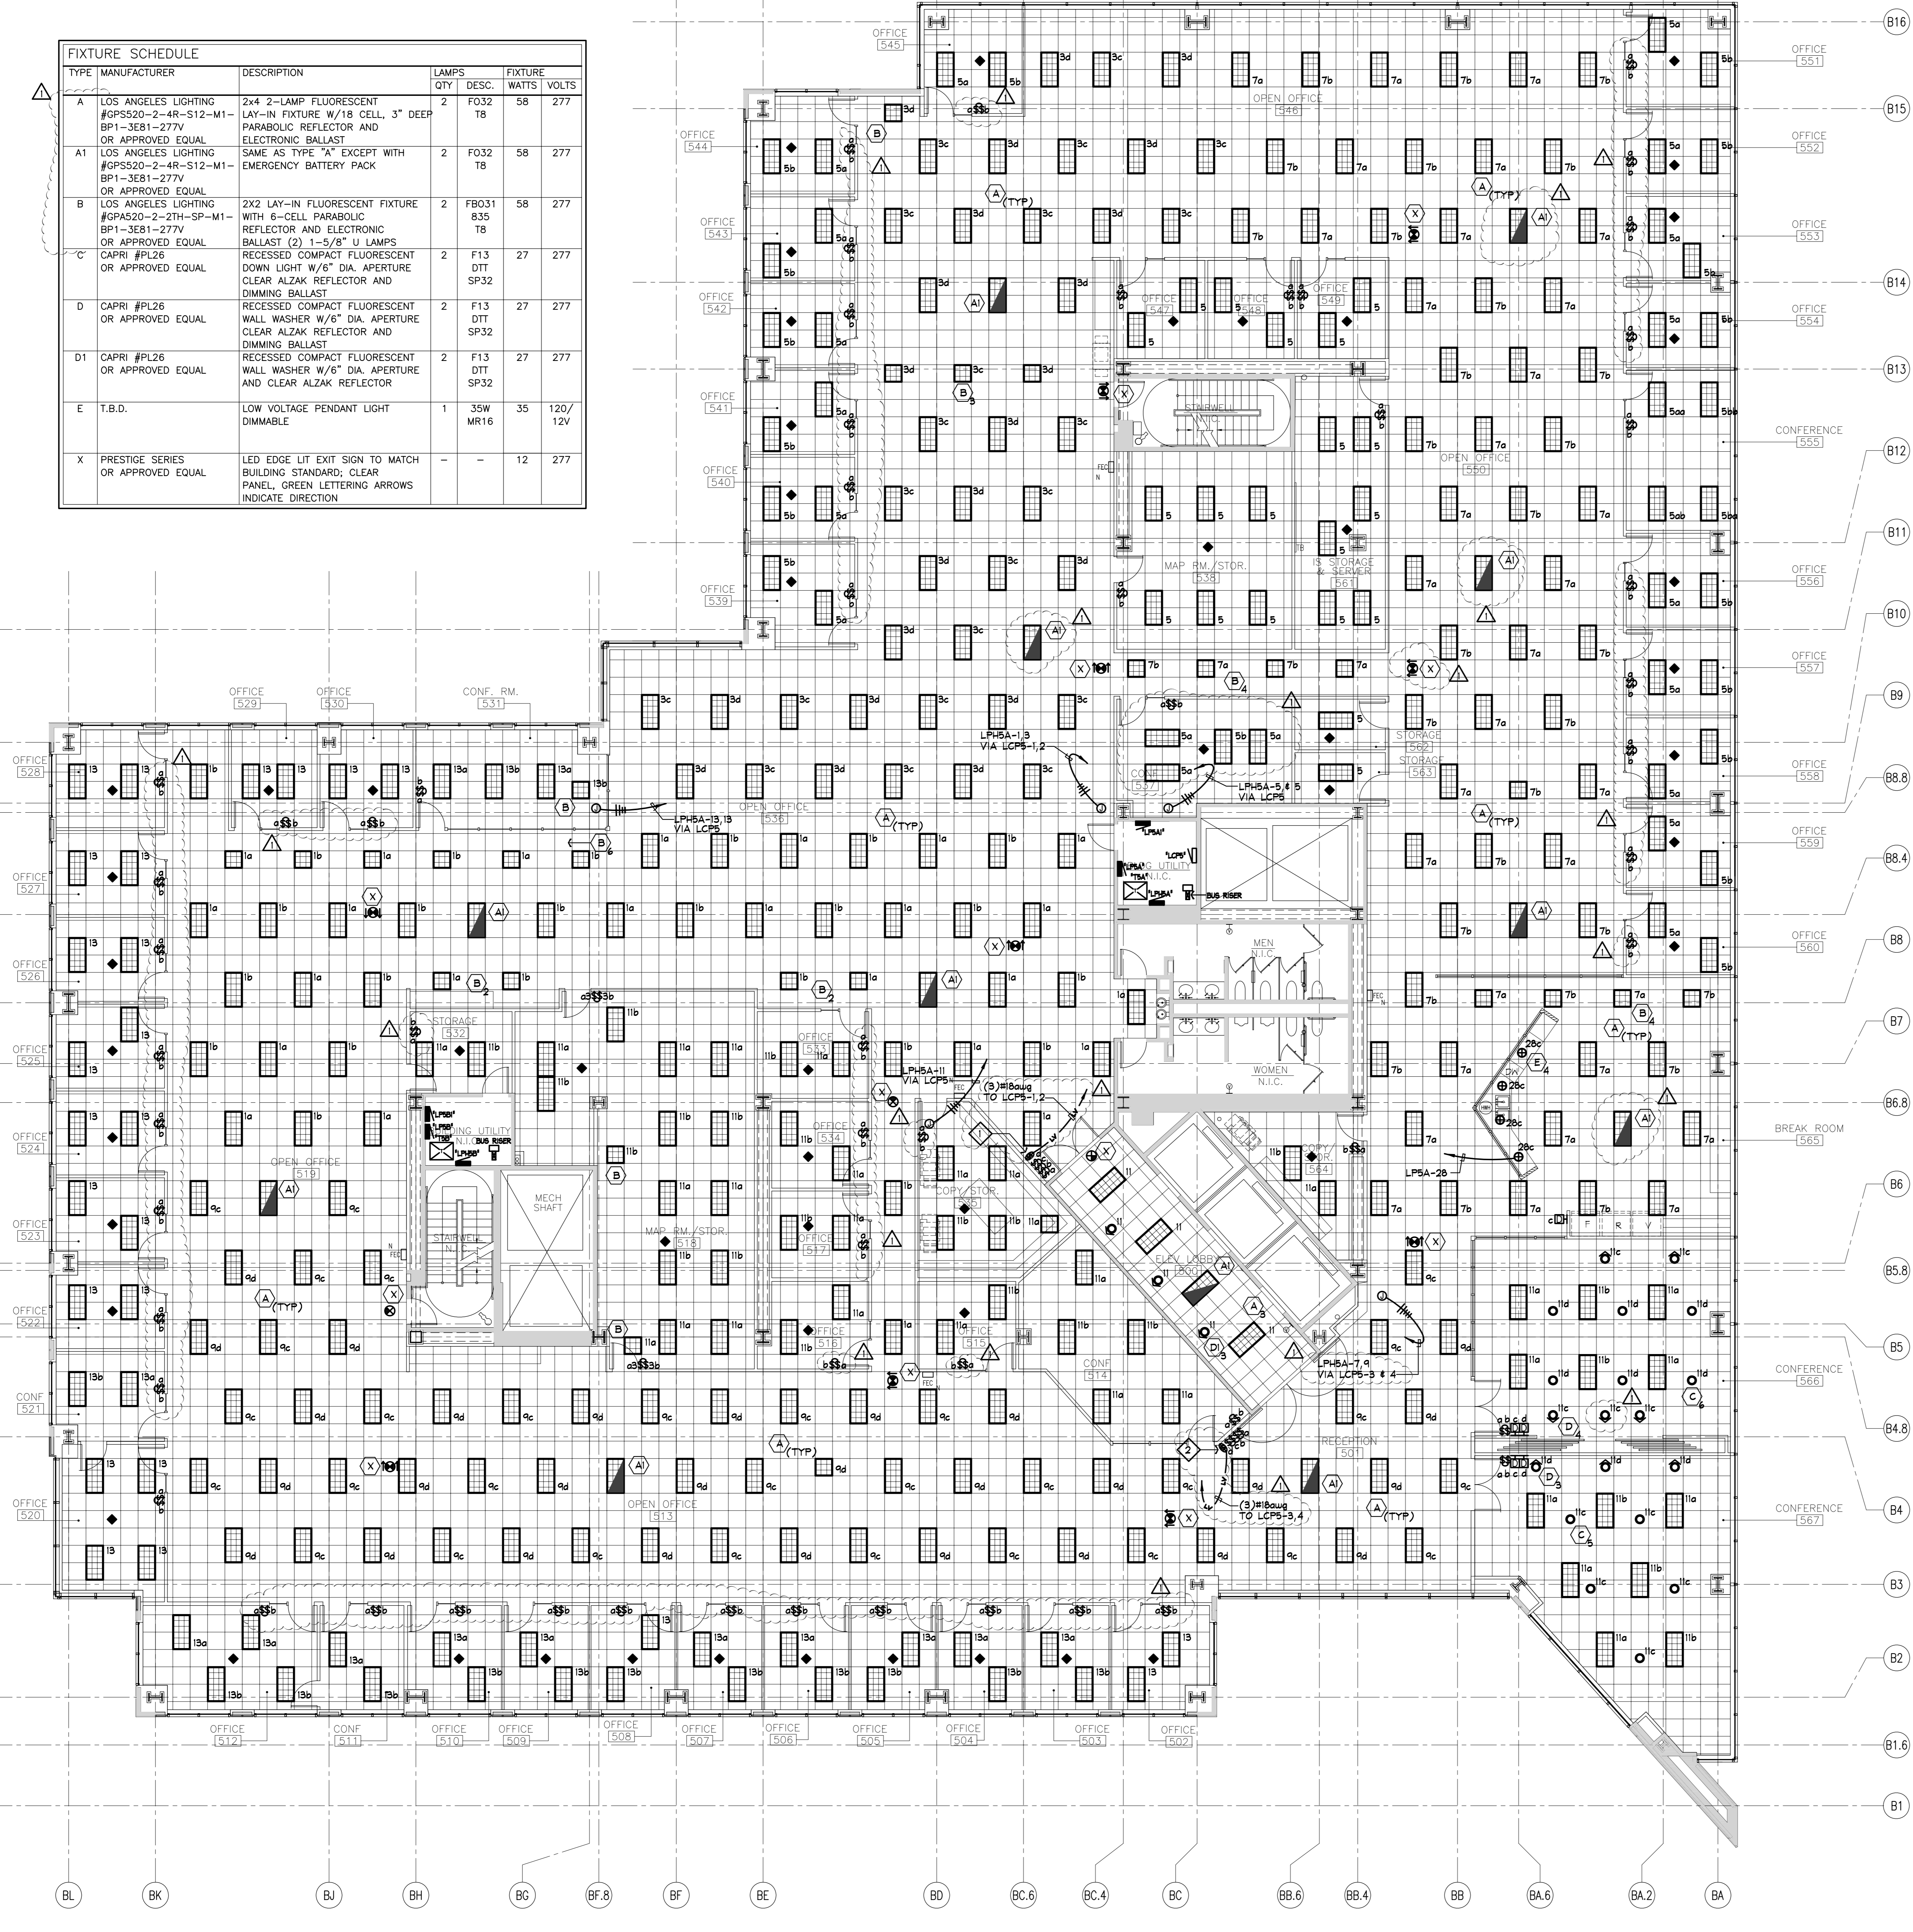


GENERAL NOTES:

- CONNECT ALL NEW EXIT SIGNS AND NIGHT LIGHT FIXTURES TO EXISTING EMERGENCY LIGHTING CIRCUIT FROM PANEL "LPH5A-2".

SHEET NOTES:

- (2) LOW VOLTAGE BY-PASS SWITCHES CONTROLLING CIRCUITS LPH5A - 1,3.
- (2) LOW VOLTAGE BY-PASS SWITCHES CONTROLLING CIRCUITS LPH5A - 7,9.

Revision	Date	Description	By
△	04/19/04	ISSUED FOR PERMIT	CEI
△	05/13/04	PLAN CHECK & TENANT REVISIONS	CEI
△			
△			
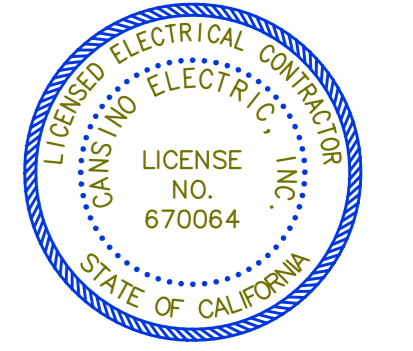

Project No.: 04-038
Date: 04/19/04
Scale: 1/8"=1'-0"
Drawn By: BCE
Checked By: CEI

5TH FLOOR LIGHTING PLAN
SHEET NUMBER
TE5.4