


**2 SECOND FLOOR LIGHTING PLAN**  
1/8"=1'-0"

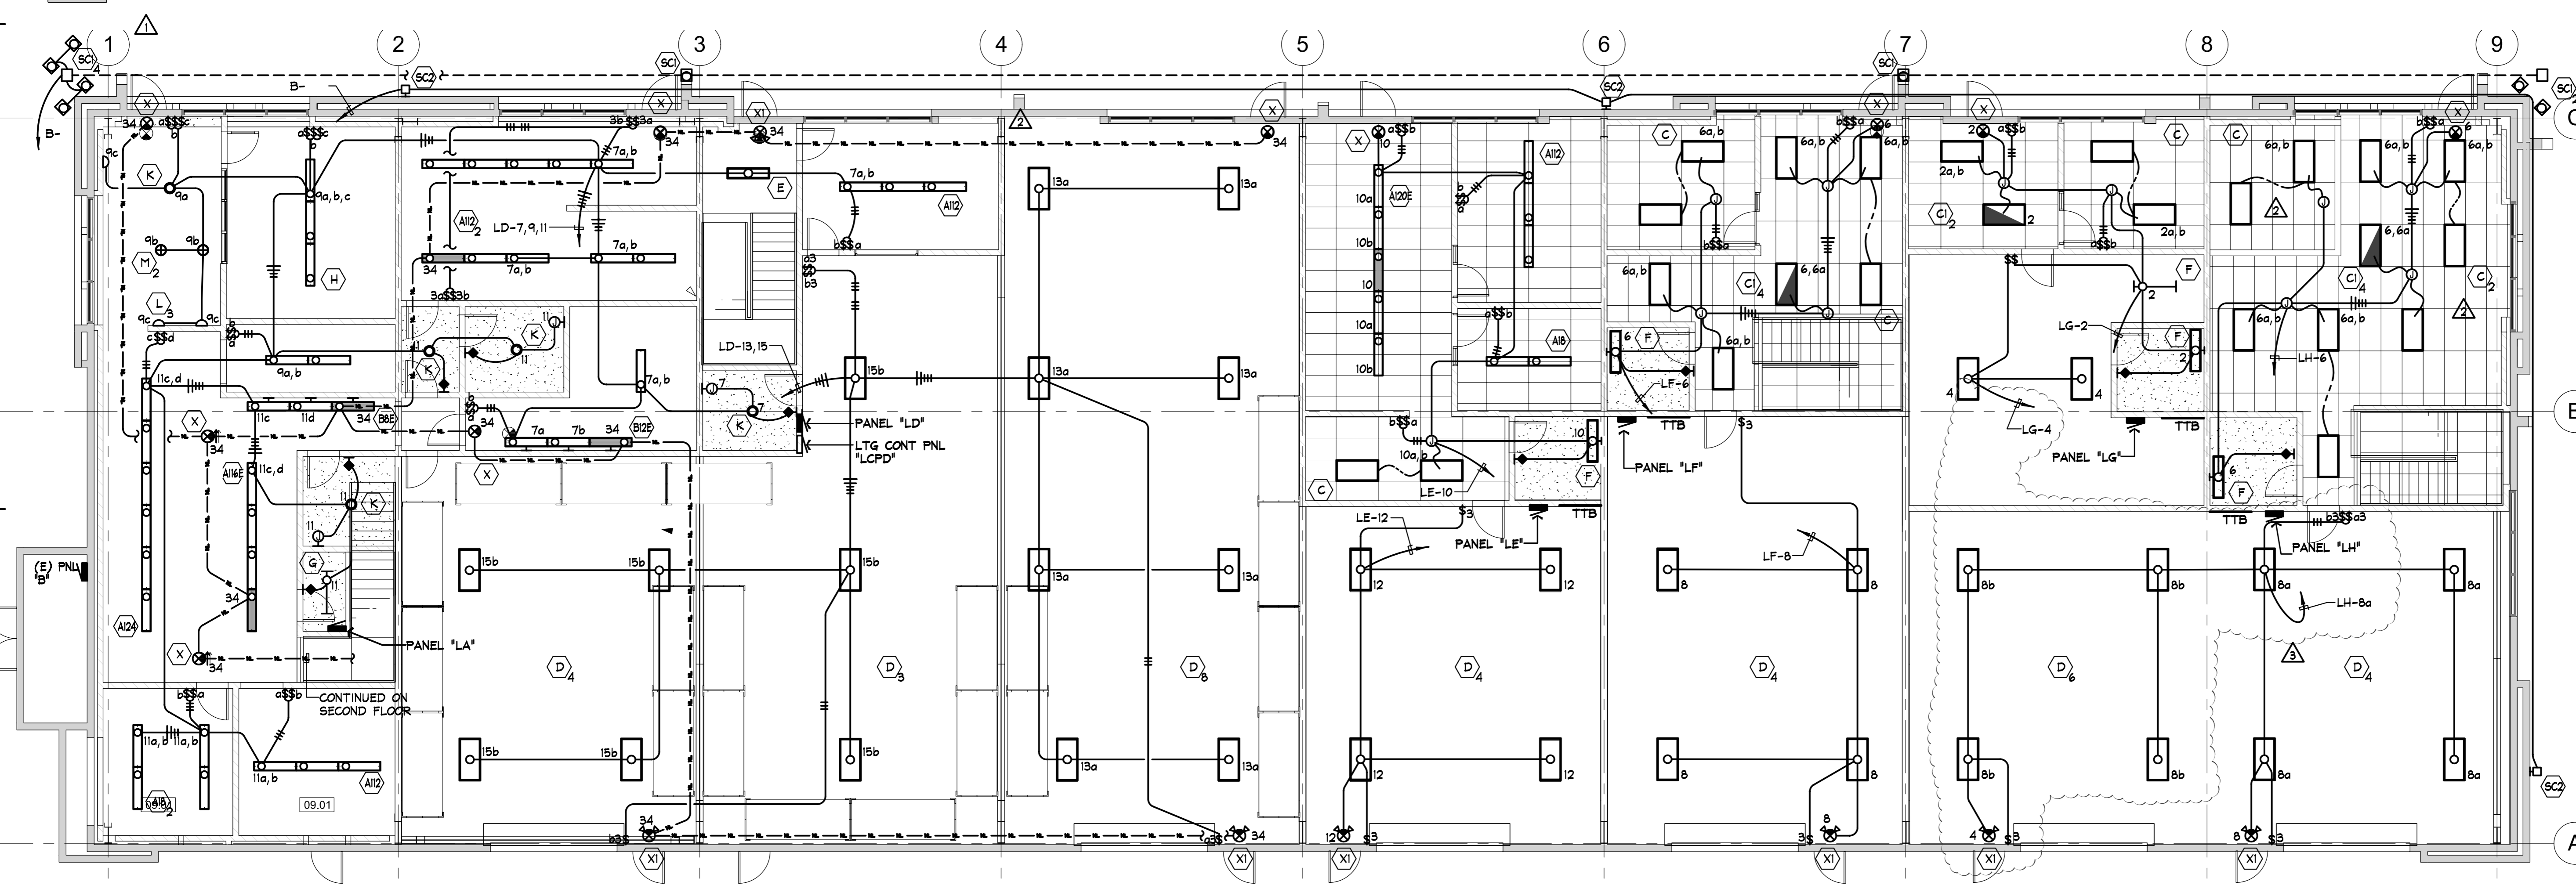

**1 FIRST FLOOR LIGHTING PLAN**  
1/8"=1'-0"

**TMW** CONSTRUCTION DESIGN BUILD MANAGEMENT & ASSOCIATES, Inc.  
1725 Sanguinetti Lane  
Stockton, California  
95205-3416  
t: 209.943.2881  
f: 209.943.0176

**Rodda Electric**  
COMMERCIAL - INDUSTRIAL  
Lic# 754354  
2420 Sand Creek Rd., C1-341  
Brentwood, CA. 94513  
(925) 240-6024

THE WITHIN DESIGN IS THE SOLE AND EXCLUSIVE PROPERTY OF RODDA ELECTRIC, AND IS NOT TO BE USED, COPIED, OR REPRODUCED, IN WHOLE OR IN PART BY ANY OTHER PERSON. EXHIBITION HEREOF IS SOLELY FOR THE PURPOSE OF EFFECTING A SALE OF THE DELINEATED ELECTRICAL DESIGN OR INSTALLATION TO CUSTOMERS OR PROSPECTIVE CUSTOMERS OF RODDA ELECTRIC.

Project Name:  
**Town & Country Business Center**  
**Tenant Improvement : Building B**

No.	Description	Date
▲	ISSUED FOR PERMIT	12.02.04
▲	GENERAL REVISION	01.14.05
▲	OWNERS REVISION	03.04.05
▲	OWNERS REVISION-- SUITE "E"	03.16.05

Project number:	04-127
Drawn by:	BCE
Checked by:	RE
Sheet title:	<b>FIRST AND SECOND FLOOR LIGHTING PLANS</b>
Sheet number:	

**E-1.1**  
Scale: 1/8"=1'-0"