


2 SECOND FLOOR POWER PLAN
1/8"=1'-0"

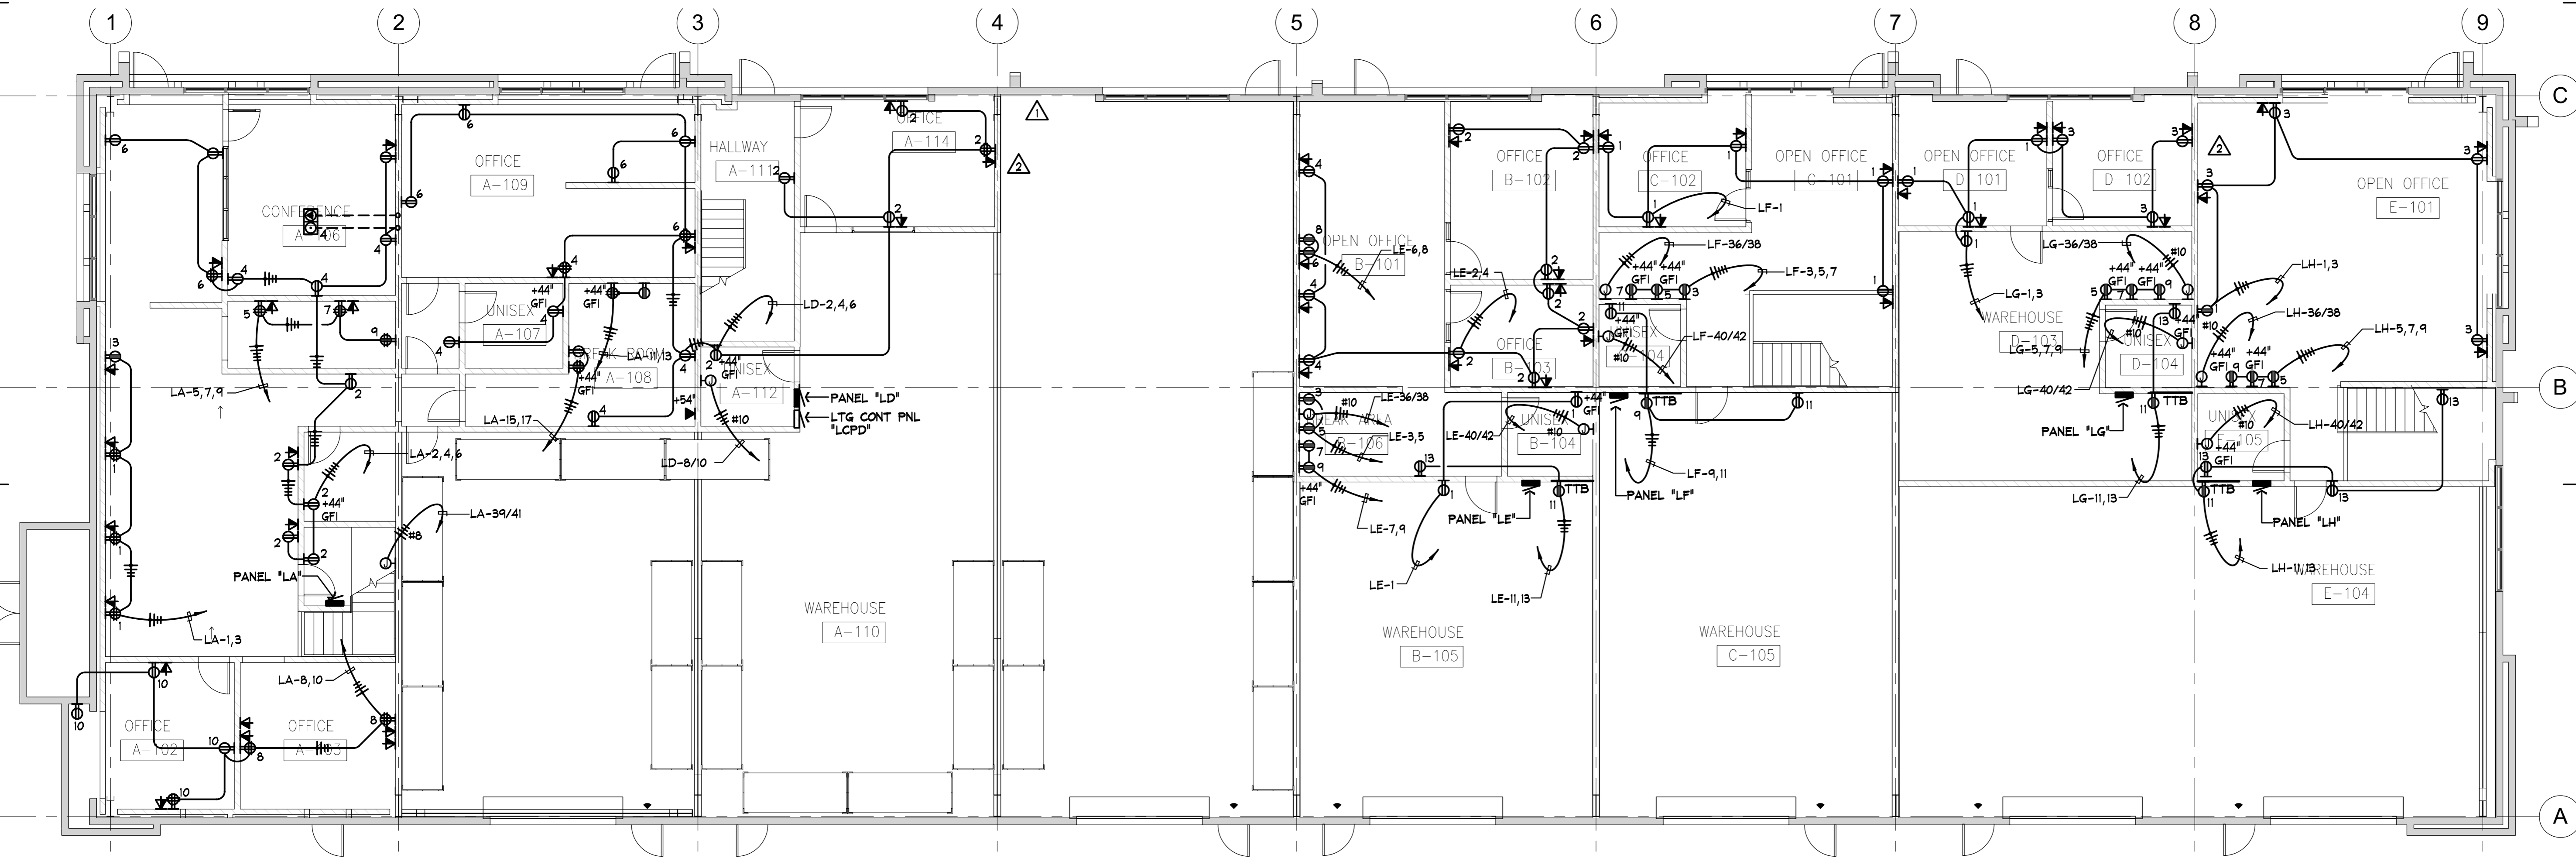

1 FIRST FLOOR POWER PLAN
1/8"=1'-0"

TMW CONSTRUCTION DESIGN BUILD MANAGEMENT & ASSOCIATES, Inc.
1725 Sanguinetti Lane
Stockton, California
95205-3416
t: 209.943.2881
f: 209.943.0176

Rodda Electric
COMMERCIAL - INDUSTRIAL
Lic# 754354
2420 Sand Creek Rd., C1-341
Brentwood, CA. 94513
(925) 240-6024

THE WITHIN DESIGN IS THE SOLE AND EXCLUSIVE PROPERTY OF RODDA ELECTRIC, AND IS NOT TO BE USED, COPIED, OR REPRODUCED, IN WHOLE OR IN PART BY ANY OTHER PERSON. EXHIBITION HEREOF IS SOLELY FOR THE PURPOSE OF EFFECTING A SALE OF THE DELINEATED ELECTRICAL DESIGN OR INSTALLATION TO CUSTOMERS OR PROSPECTIVE CUSTOMERS OF RODDA ELECTRIC.

Project Name:
Town & Country Business Center
Tenant Improvement : Building B

No.	Description	Date
1	ISSUED FOR PERMIT	12.02.04
2	GENERAL REVISION	01.14.05
3	OWNERS REVISION	03.04.05

Project number: 04-127

Drawn by: BCE
Checked by: RE

Sheet title:
FIRST AND SECOND FLOOR POWER PLANS

Sheet number:

Scale: 1/8"=1'-0"

E-2.1