


THE WITHIN DESIGN IS THE SOLE AND EXCLUSIVE PROPERTY OF RODDA ELECTRIC, AND IS NOT TO BE USED, COPIED, OR REPRODUCED, IN WHOLE OR IN PART BY ANY OTHER PERSON. EXHIBITION HEREOF IS SOLELY FOR THE PURPOSE OF EFFECTING A SALE OF THE DELINEATED ELECTRICAL DESIGN OR INSTALLATION TO CUSTOMERS OR PROSPECTIVE CUSTOMERS OF RODDA ELECTRIC.

Project Name:
Town & Country Business Center
Tenant Improvement : Building B

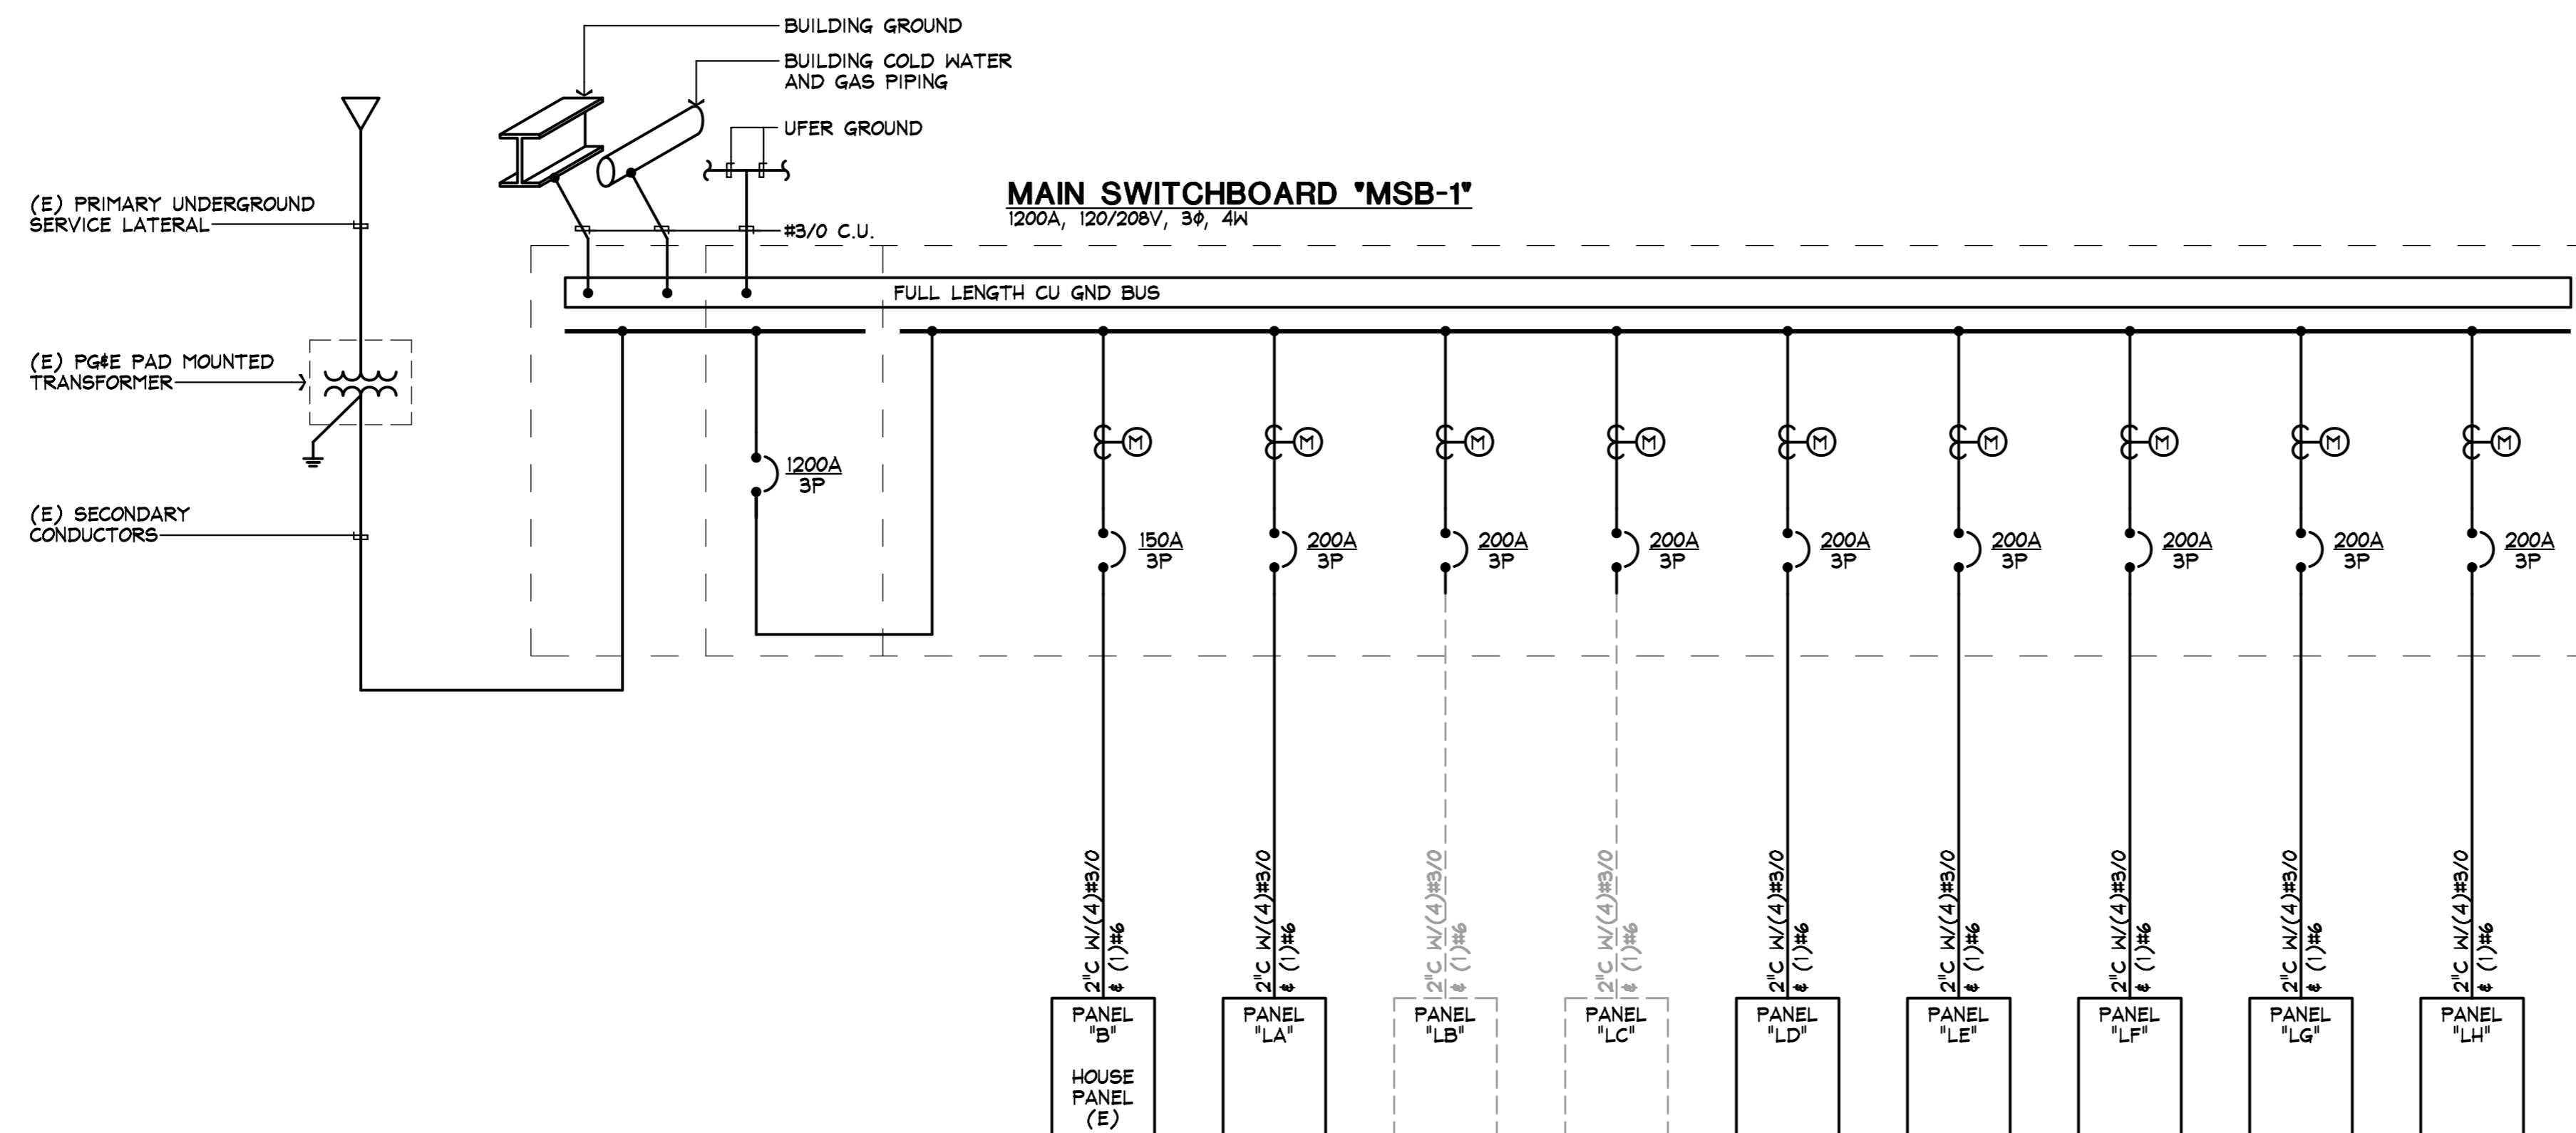

LOAD SUMMARY - "MSB"	
RECEPTACLE	66.96 KVA
1ST 10 KVA AT 100%	10.00 KVA
REMAINING AT 50%	28.48 KVA
LIGHTING AT 125% =	23.32 KVA
MOTOR LOADS =	97.49 KVA
EQUIPMENT =	47.76 KVA
EXISTING LOAD =	15.00 KVA
TOTAL =	222.05 KVA
	616.79 AMPS @ 208 V 3 PHASE

1 SINGLE LINE DIAGRAM
 - NONE

No.	Description	Date
-	ISSUED FOR PERMIT	12.02.04
△	GENERAL REVISION	01.14.05
△	OWNERS REVISION	03.04.05

Project number: 04-127

Drawn by: BCE

Checked by: RE

Sheet title:
SINGLE LINE DIAGRAM

Sheet number:

E-0.4

Scale: NONE